



NOTES

1. REFER TO SITE PLAN FOR CONTINUATION.
2. 4" SANITARY DOWN FROM WATER CLOSET. REFER TO SHEET P110 FOR CONTINUATION.
3. 3" SANITARY DOWN FROM LAVATORY/SINK. REFER TO SHEET P110 FOR CONTINUATION.
4. 3" SANITARY DOWN FROM FLOOR DRAIN. REFER TO SHEET P110 FOR CONTINUATION.
5. 3" SANITARY DOWN FROM MOP BASIN. REFER TO SHEET P110 FOR CONTINUATION.
6. 4" SANITARY DOWN FROM CLINICAL SERVICE SINK. REFER TO SHEET P110 FOR CONTINUATION.
7. 3" SANITARY DOWN FROM FLOOR SINK. REFER TO SHEET P110 FOR CONTINUATION.
8. 3" SANITARY DOWN FROM SIT-IN TUB. REFER TO SHEET P110 FOR CONTINUATION. COORDINATE CONNECTION WITH EQUIPMENT SUPPLIER.
9. 4" SANITARY DOWN FROM FLOOR SINK. REFER TO SHEET P110 FOR CONTINUATION.
10. 3" SANITARY DOWN FROM LAUNDRY BOX. REFER TO SHEET P110 FOR CONTINUATION.
11. 3" SANITARY DOWN FROM WASHING MACHINE. REFER TO SHEET P110 FOR CONTINUATION. COORDINATE CONNECTION WITH EQUIPMENT SUPPLIER.
12. 3" SANITARY DOWN FROM LAUNDRY TUB. REFER TO SHEET P110 FOR CONTINUATION.
13. PROVIDE WATER TIGHT SLEEVE.
14. 3" SANITARY FROM ABOVE. REFER TO SHEET P110 FOR CONTINUATION.
15. 3" SANITARY DOWN FROM ELECTRIC WATER COOLER. REFER TO SHEET P110 FOR CONTINUATION.
16. 4" SANITARY FROM STRAINER UNDER PRE-RINSE. REFER TO SHEET P110 FOR CONTINUATION.
17. 2" VENT UP. REFER TO SHEET P110 FOR CONTINUATION.
18. 6" GAS UP. REFER TO SHEET M300 FOR CONTINUATION.
19. 3" CW UP. REFER TO SHEET M300 FOR CONTINUATION.

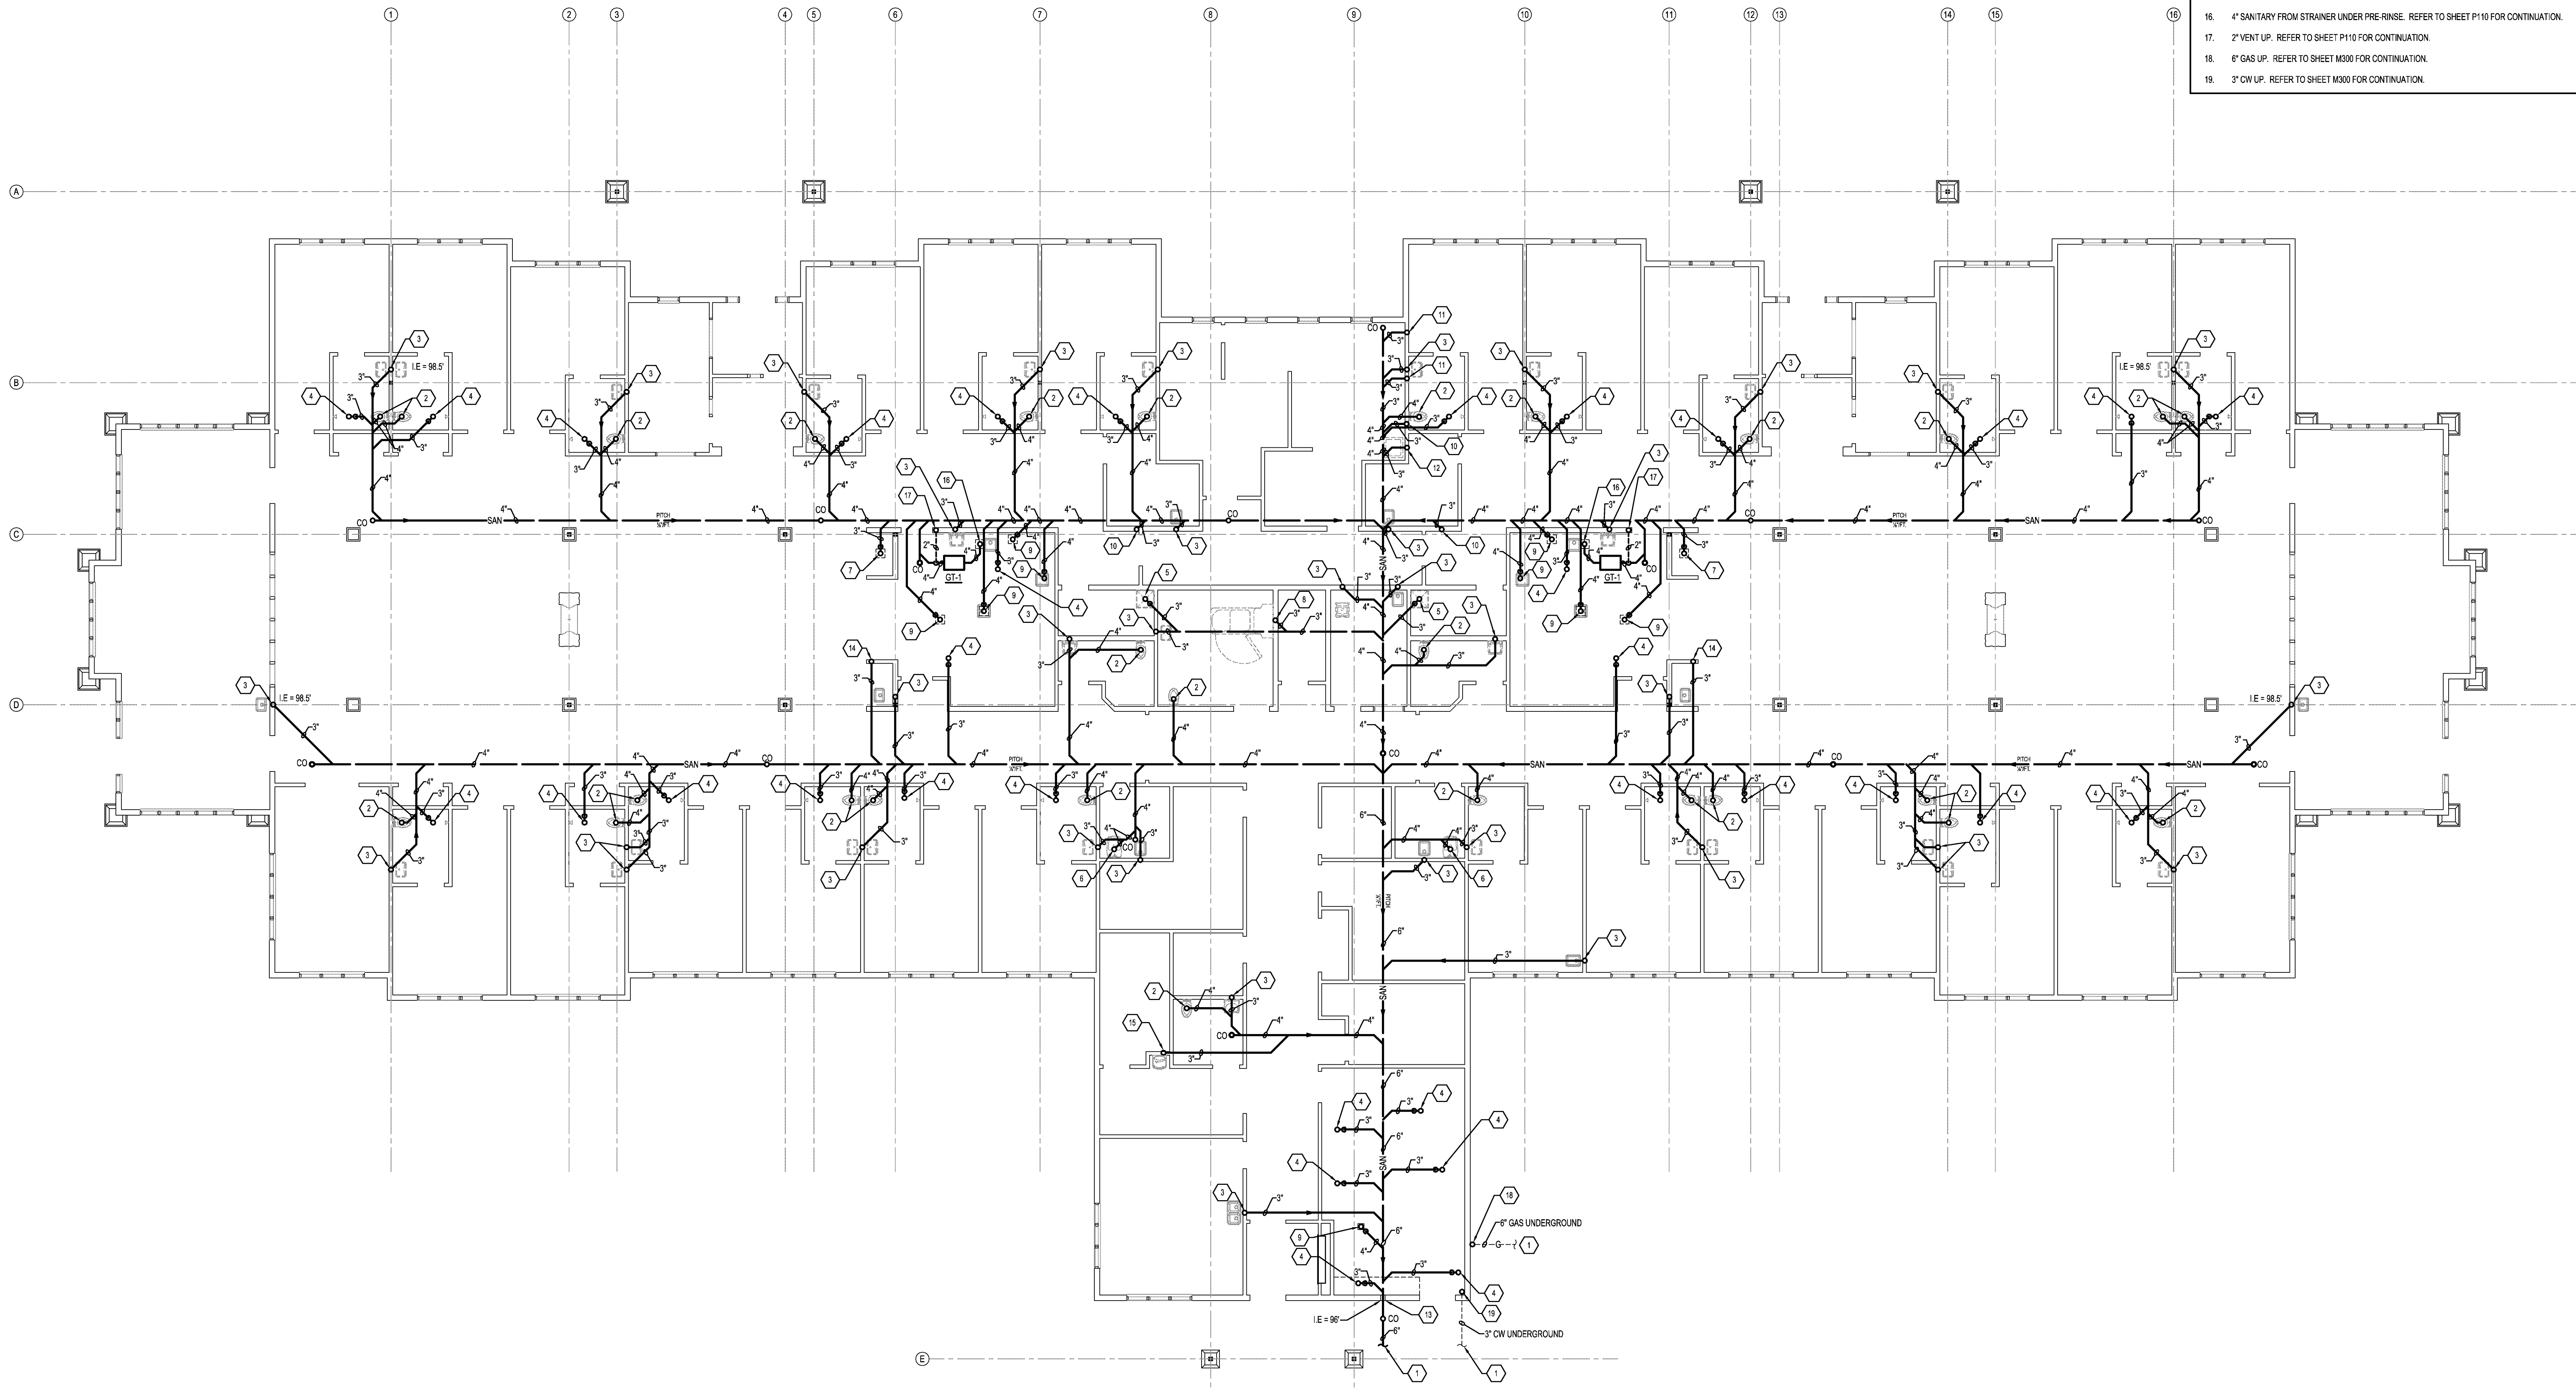

1 UNDERGROUND PLUMBING PLAN

SCALE: 1/8"=1'-0"
FINISHED FLOOR ELEVATION: 100.0' (812.0')

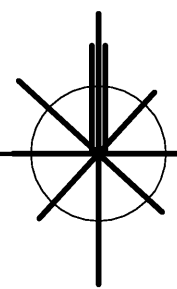

THE COTTAGE at THORNAPPLE
Hastings, MI

PROJ. NO.: 2011-11-021

02/21/12 ISSUED FOR BIDS

CONSTRUCTION MANAGER
CM CONTRACTING
CIVIL ENGINEER
HURLEY & STEWART
STRUCTURAL ENGINEER
JDH ENGINEERING
MECHANICAL ENGINEER
E2W ENGINEERING
PLUMBING SERVICE CONSULTANT
MILLIS & ASSOCIATES

ECKERT WORDELL
ARCHITECTURE • ENGINEERING • INTERIOR DESIGN
161 East Michigan Ave, Suite 200
Kalamazoo, MI 49007-3807
PHONE: 269-388-7313
FAX: 269-388-7300
WEB: www.eckert-wordell.com
© 2011 Eckert Wordell, LLC

UNDERGROUND PLUMBING PLAN

P100