



Wilkie & Zanley

ENGINEERS • ARCHITECTS • CONSULTANTS • PROJECT MANAGERS

"A Sidcock Company"

Wyandotte Office
4242 Biddle Avenue
Wyandotte, Michigan 48192
Ph: (734)285-1924 • Fax: (734)285-2833

Main Headquarters
43155 Main Street, Suite 2310
Novi, Michigan 48375
Ph: (248)349-4500 • Fax: (248)349-1429

West Michigan Office
379 W. Western Avenue, Suite 200
Muskegon, Michigan 49440
Ph: (231)722-4900 • Fax: (231)722-4955

www.sidcockgroup.com

Key Plan: NO SCALE

Client:
NORTHVILLE PUBLIC SCHOOLS

Project:
COOKE SCHOOL
MISCELLANEOUS
RENOVATIONS

21200 TAFT RD.
NORTHVILLE, MICHIGAN 48167
Seat:

Date: 05-21-2012 Issued For: BIDDING

Drawn: JAG
Checked: DMZ
Approved: DMZ


Sheet Title:
**ELECTRICAL
POWER PLAN /
LIGHTING PLAN**

AREAS 4 & 5


Project Number: 312081

Sheet Number: **E-102**


THE MATERIALS & THE EXCLUSIVE PROPERTY OF SIDCOCK GROUP, INC. AND
CONTRACTOR'S RESPONSIBILITY. CONSULT WITH AN ENGINEER BEFORE THE
PAPER IS REPRODUCED OR COPIED IN ANY MANNER WITHOUT THE
PERMISSION OF SIDCOCK GROUP, INC. © 2011

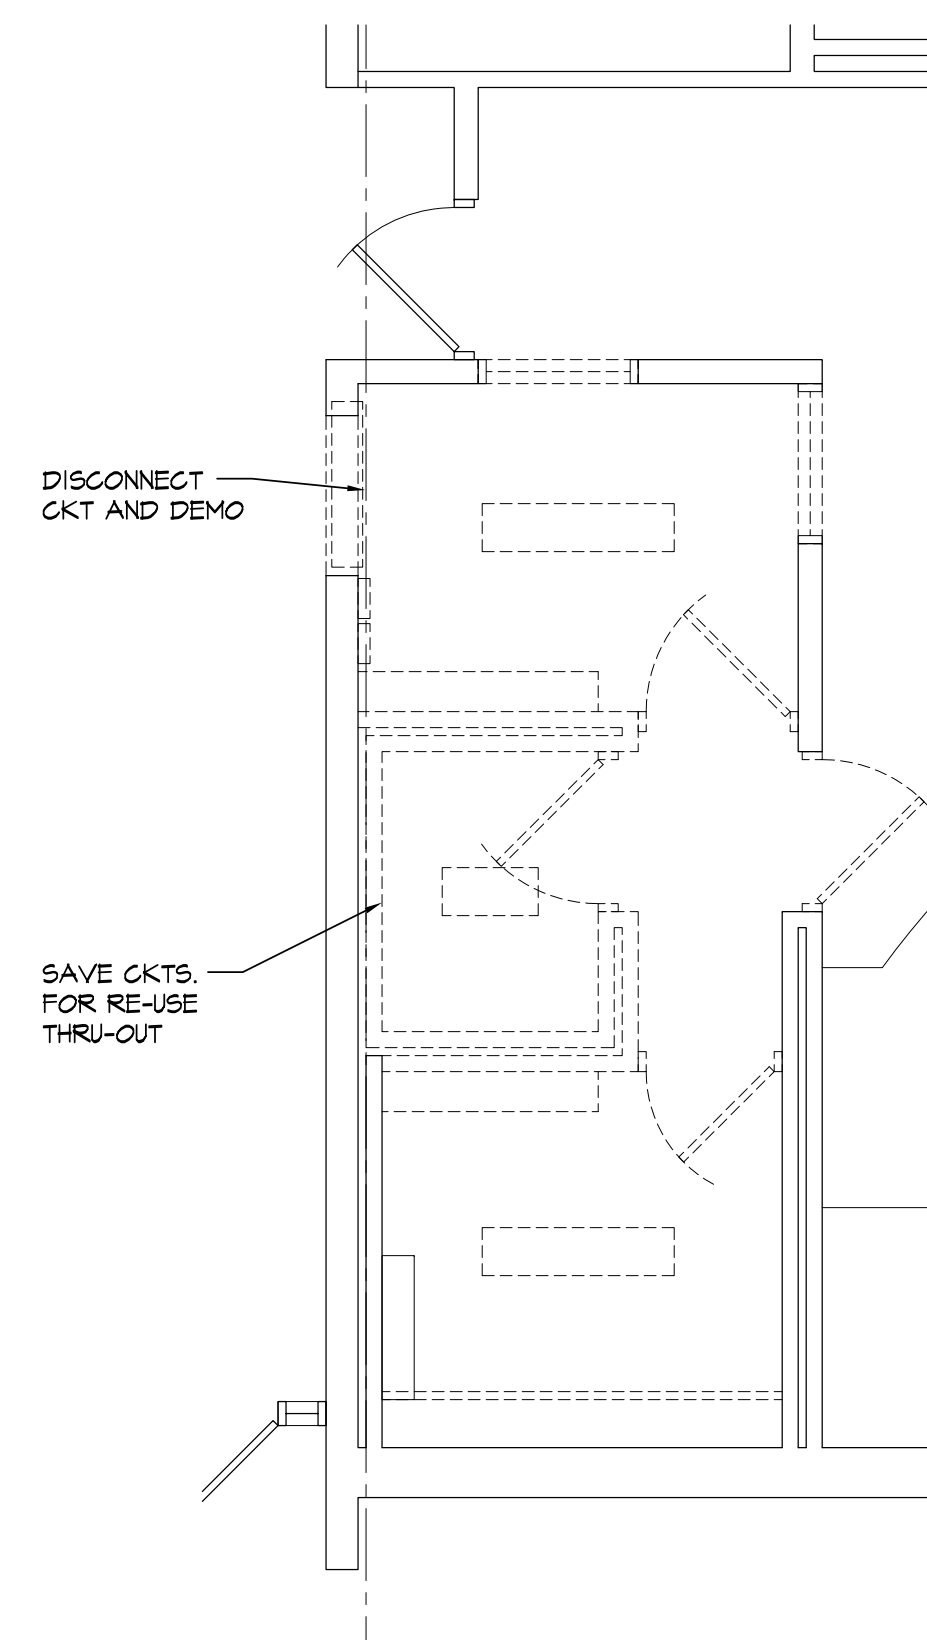

EXISTING ELECTRICAL PLAN- DEMO.

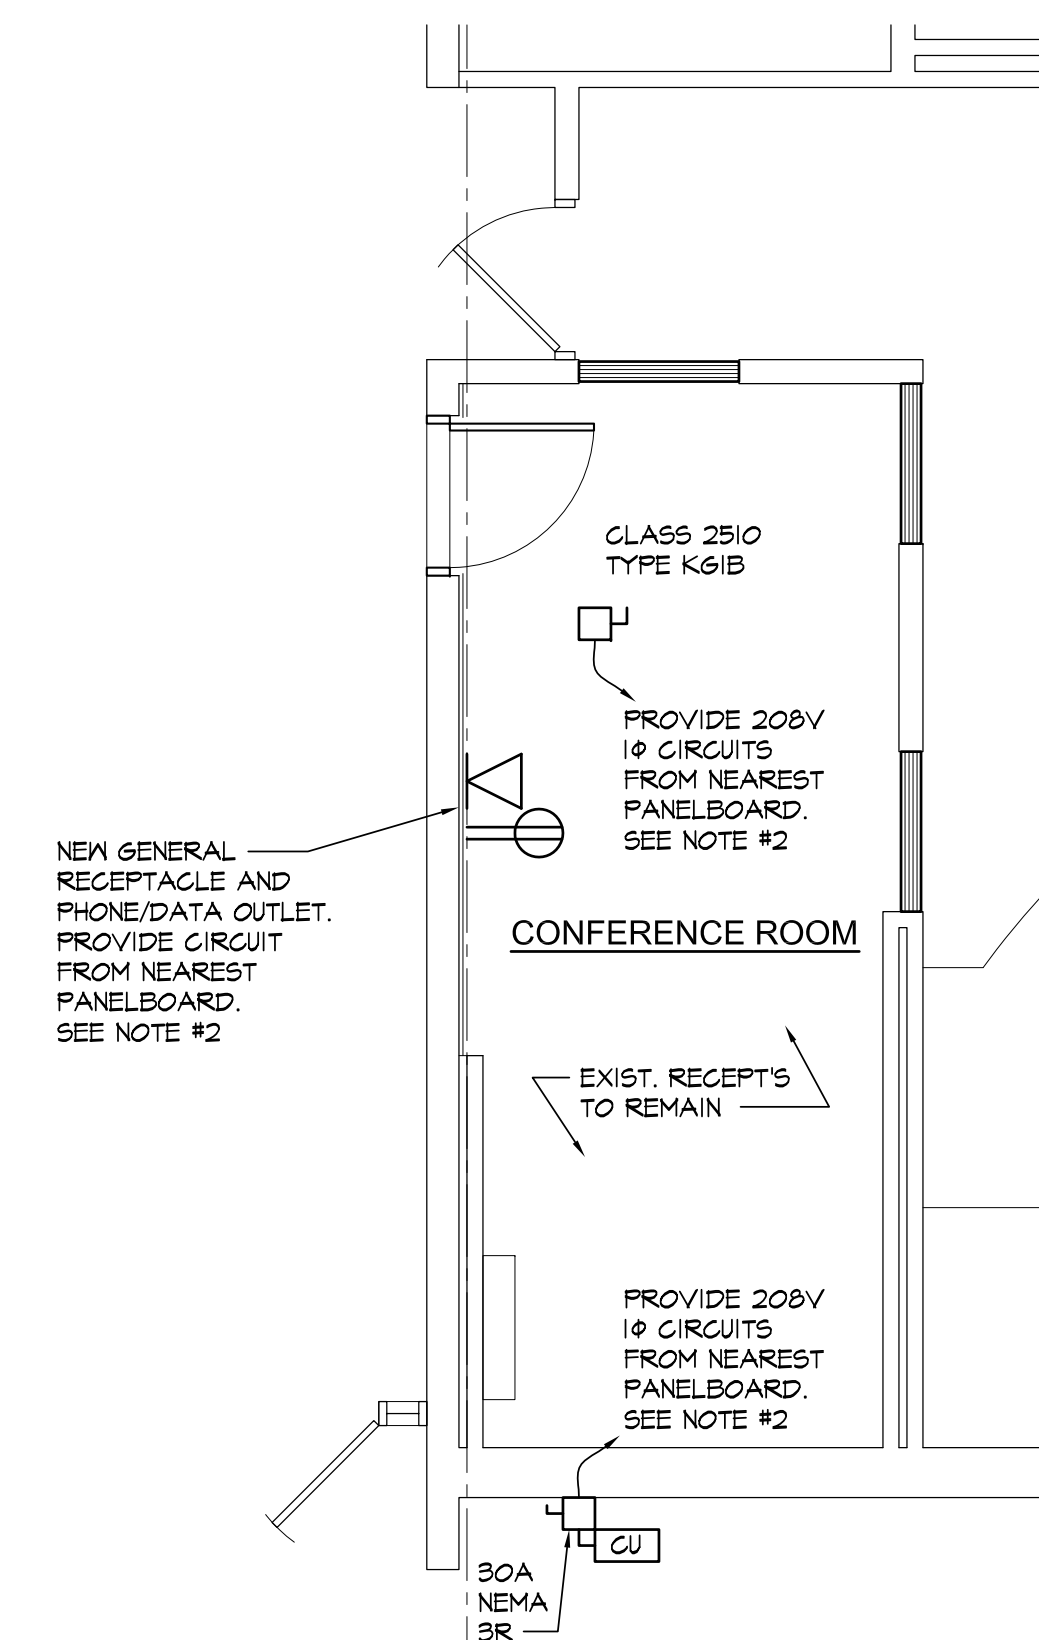


ELECTRICAL POWER PLAN

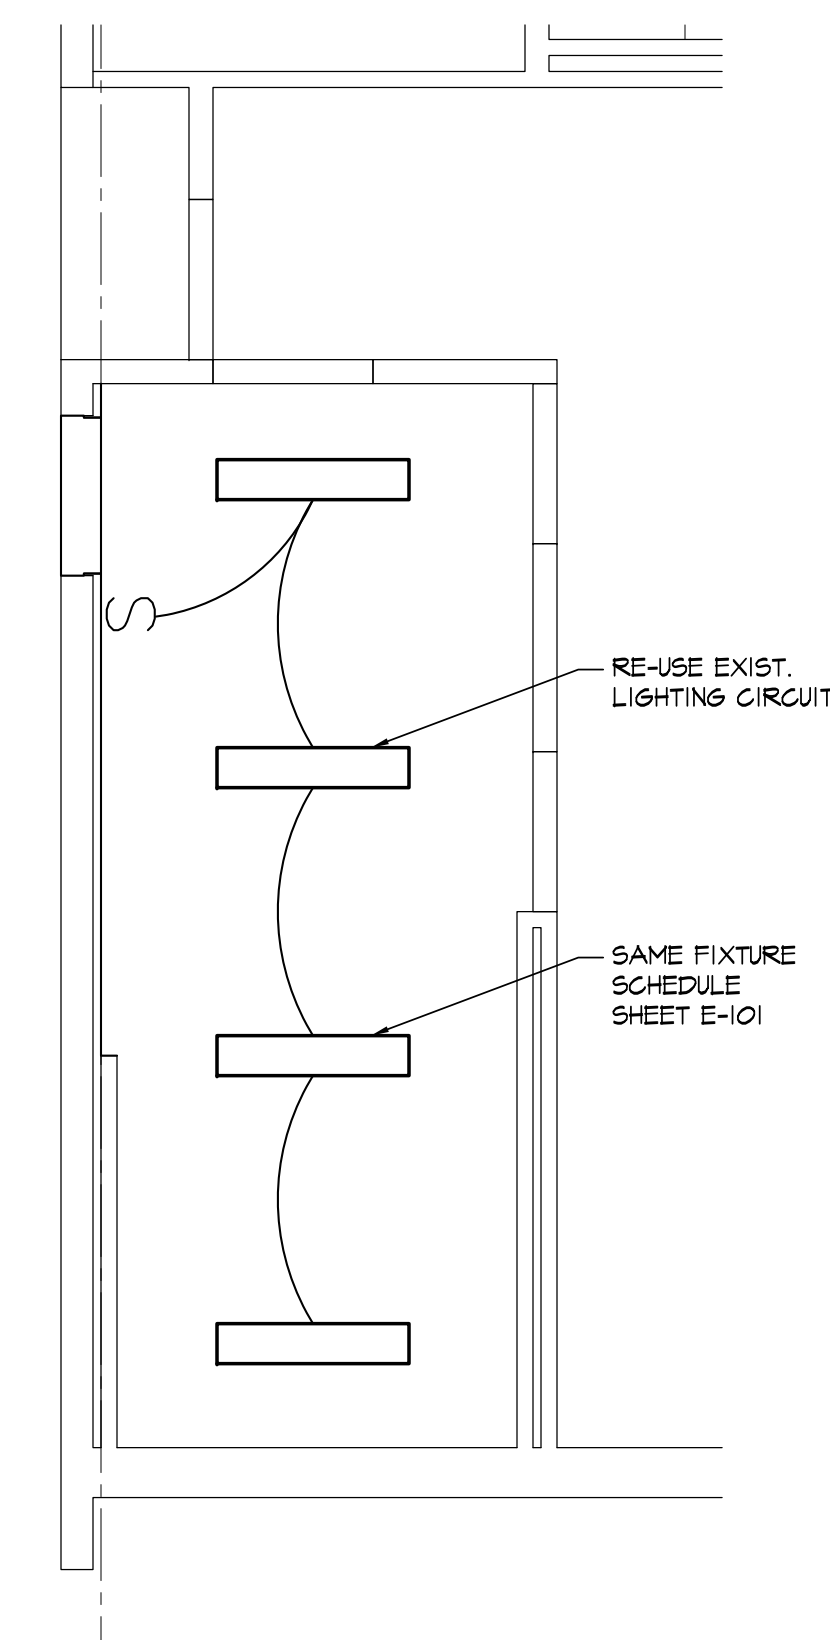


ELECTRICAL LIGHTING PLAN

2
E-102 PARTIAL LARGE SCALE PLANS- AREA 4
SCALE: 1/4"=1'0"

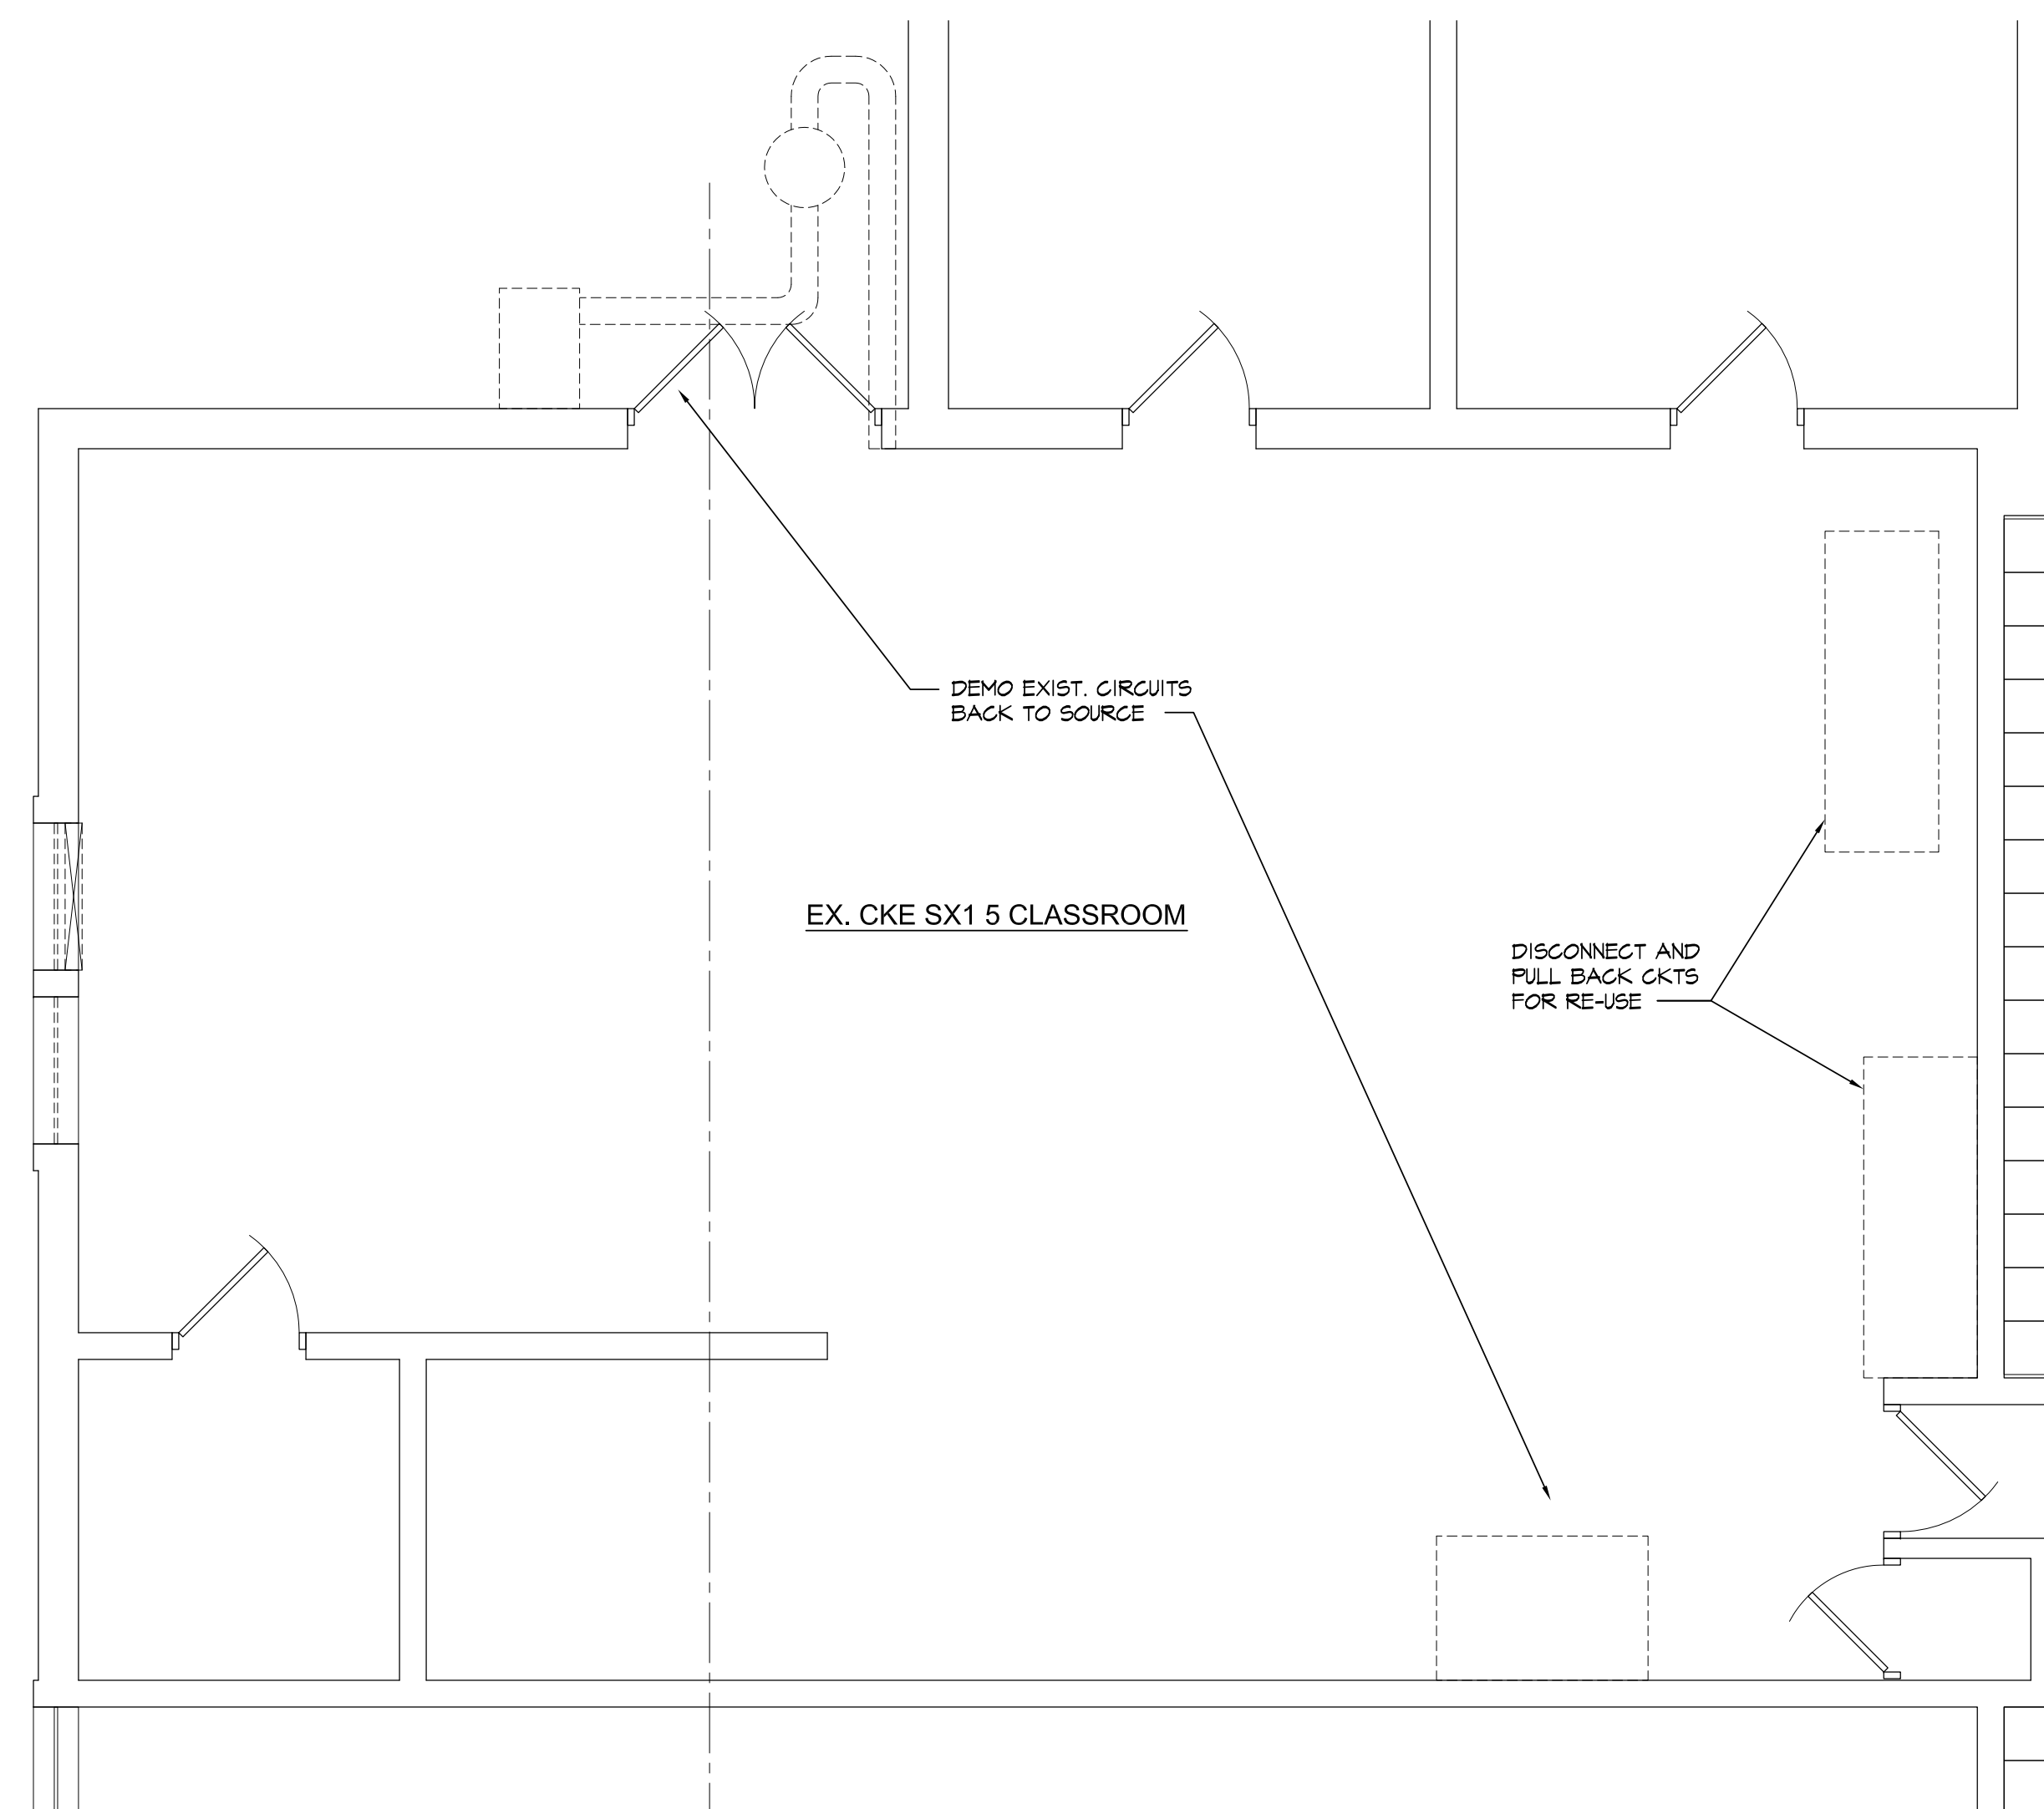

EXISTING FLOOR PLAN- DEMO.

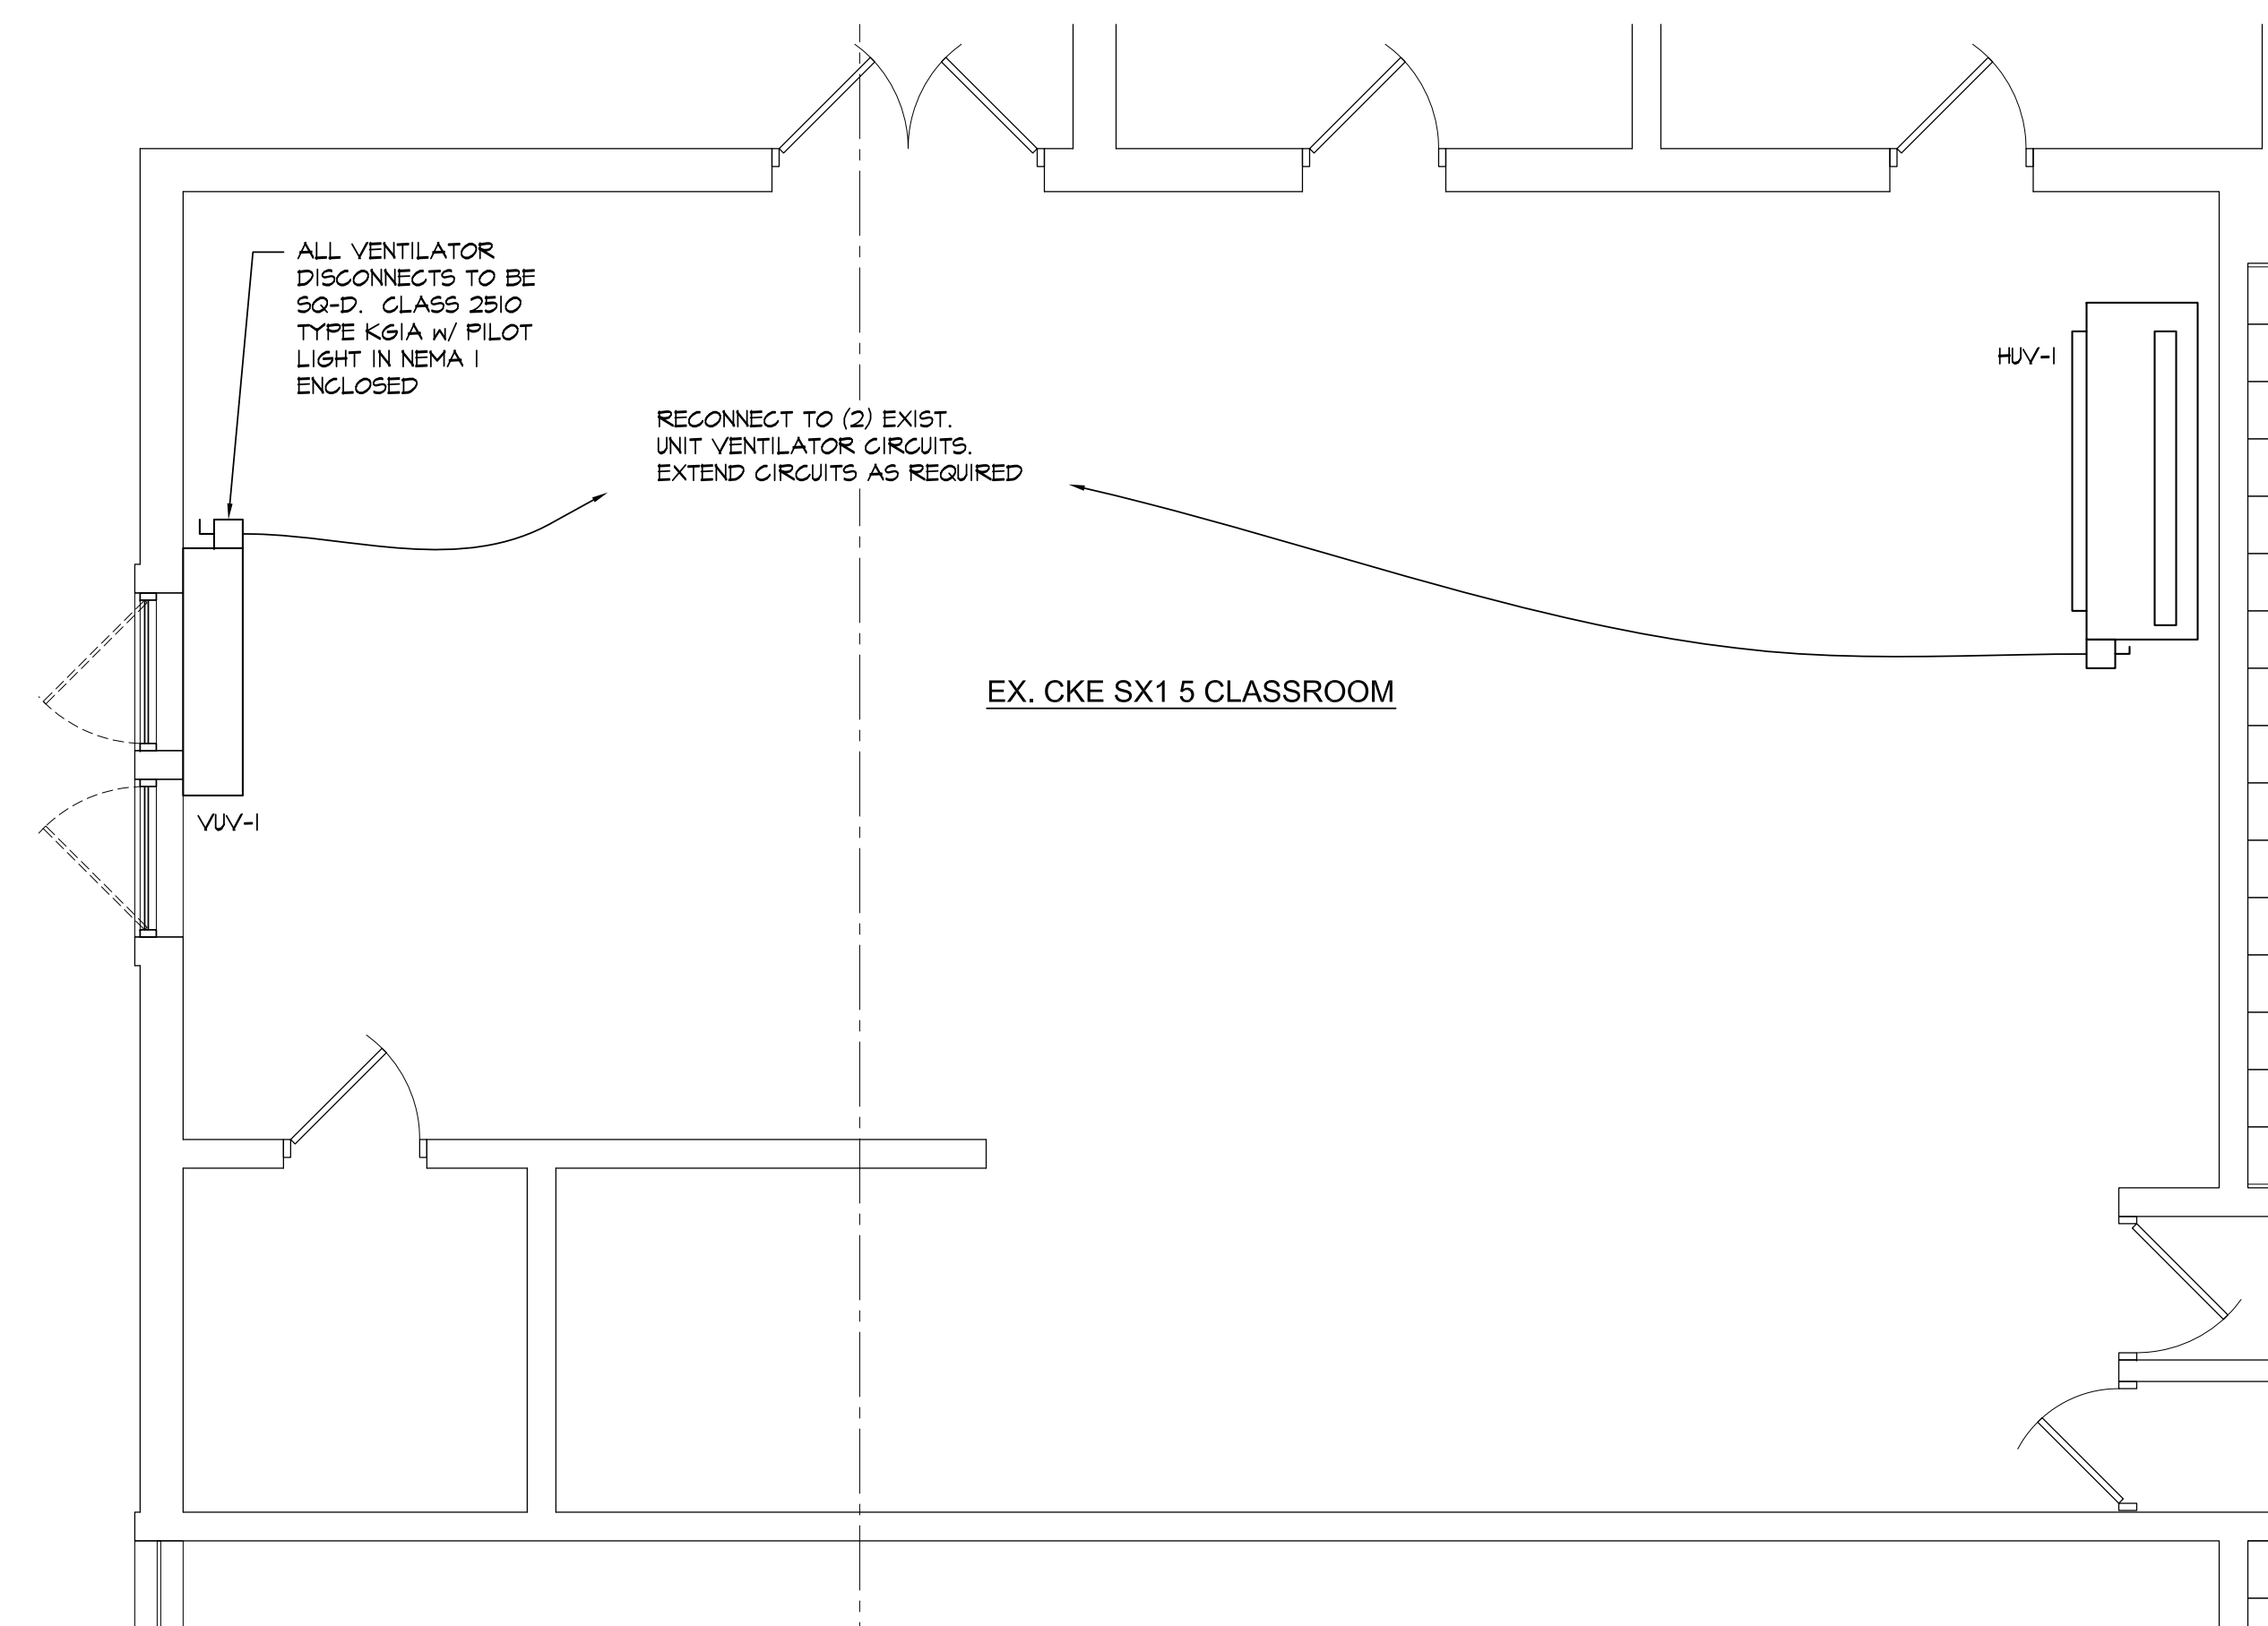

PROPOSED FLOOR PLAN

1
E-102 PARTIAL LARGE SCALE PLANS- AREA 5
SCALE: 1/4"=1'0"

F:\2012\312081 Cooke Junior High School\CAD Drawings\312081_C_E-102.dwg Thu, 17 May 2012 - 11:16pm